


CLIENT
THE COLLEGE OF NEW JERSEY
2000 PENNINGTON ROAD
EWING, NJ 08618

CIVIL ENGINEER

akrf

AKRF, INC.
ONE WASHINGTON SQUARE
530 WALNUT STREET, SUITE 998
PHILADELPHIA, PA 19106
T: 267.585.4839
F: 267.585.4840

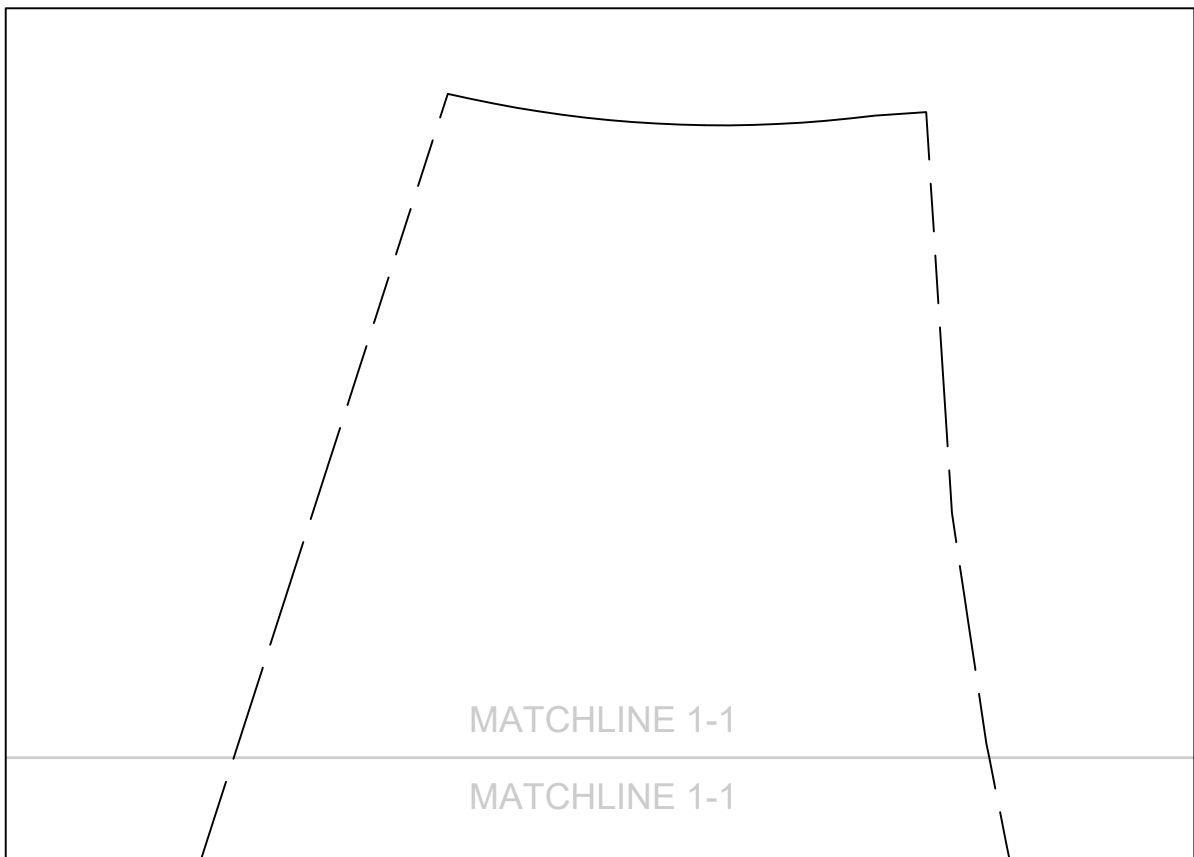

MATCHLINE 1-1

MATCHLINE 1-1

MATCHLINE 1-1

GENERAL SHEET NOTES

- THIS CAMPUS UTILITY SITE PLAN HAS BEEN DEVELOPED FROM A COMPILATION OF EXISTING CAMPUS AND BUILDING SITE DRAWINGS. THE PLAN IDENTIFIES GENERAL ROUTINGS OF THE UTILITY AND DOES NOT REPRESENT EXACT UTILITY LOCATION. PRIOR TO THE PERFORMANCE OF ANY UTILITY WORK AND/OR NEW CONSTRUCTION, A DETAILED SURVEY OF THE AFFECTED AREA SHALL BE PERFORMED TO IDENTIFY EXACT UTILITY LOCATIONS AND DEPTHS.
- DURING TIME OF INSPECTION, SEVERAL AREAS OF THE CAMPUS WERE UNDER CONSTRUCTION AND INLETS IN THE AFFECTED REGIONS ARE SUBJECT TO CHANGE. IN ORDER TO ENSURE ACCURACY OF THE MAP, ONCE ALL CONSTRUCTION ACTIVITIES HAVE CONCLUDED, THE AFFECTED REGIONS SHOULD HAVE SITE FEATURES VERIFIED.

LEGEND

	STORMWATER INLET		PUBLIC COMPLEX EXTENTS
SDXX	EXISTING STORMWATER INLET LABEL		OUTFALLS
SDXX (NA)	STORMWATER INLET - REMOVED FROM INSPECTION LIST		OUTFALL LABEL
SDXX (NC)	STORMWATER INLET - NEVER CONSTRUCTED		CULVERT
	STORMWATER MANHOLE		CULVERT LABEL
			BMP LOCATION
			BMP LABEL

CAMPUS STORM WATER MAP

Scale: 1"=150'-0"
0 150' 300'

REVISIONS

No.	DATE	DESCRIPTION

PROJECT

THE COLLEGE OF NEW JERSEY

DRAWN BY

CHECKED BY

SCALE

DATE

SHEET TITLE

STORMWATER SYSTEM MASTER MAP

SHEET NO.